 




GRAPHIC SCALE



Allen & Hoshall  
5805 Lee Highway, Suite 204 Chattanooga, TN 37421  
423.892.1203 fax 423.892.1273

**COPYRIGHT**  
Allen & Hoshall  
This document is proprietary to Allen & Hoshall and shall not be reproduced or used by others without prior written consent.

**WEST AIRFIELD APRON  
CONTRACT 2**


CHATTANOOGA METROPOLITAN AIRPORT  
CHATTANOOGA, TENNESSEE

No.	Revision	Date

**PHASING & SECURITY PLAN**

JOB NO.: 71540  
DATE: 04.16.2009  
DRAWN: ELA  
CHECKED: GRH  
CAD FILE: G01-3.DWG

**G1.3**

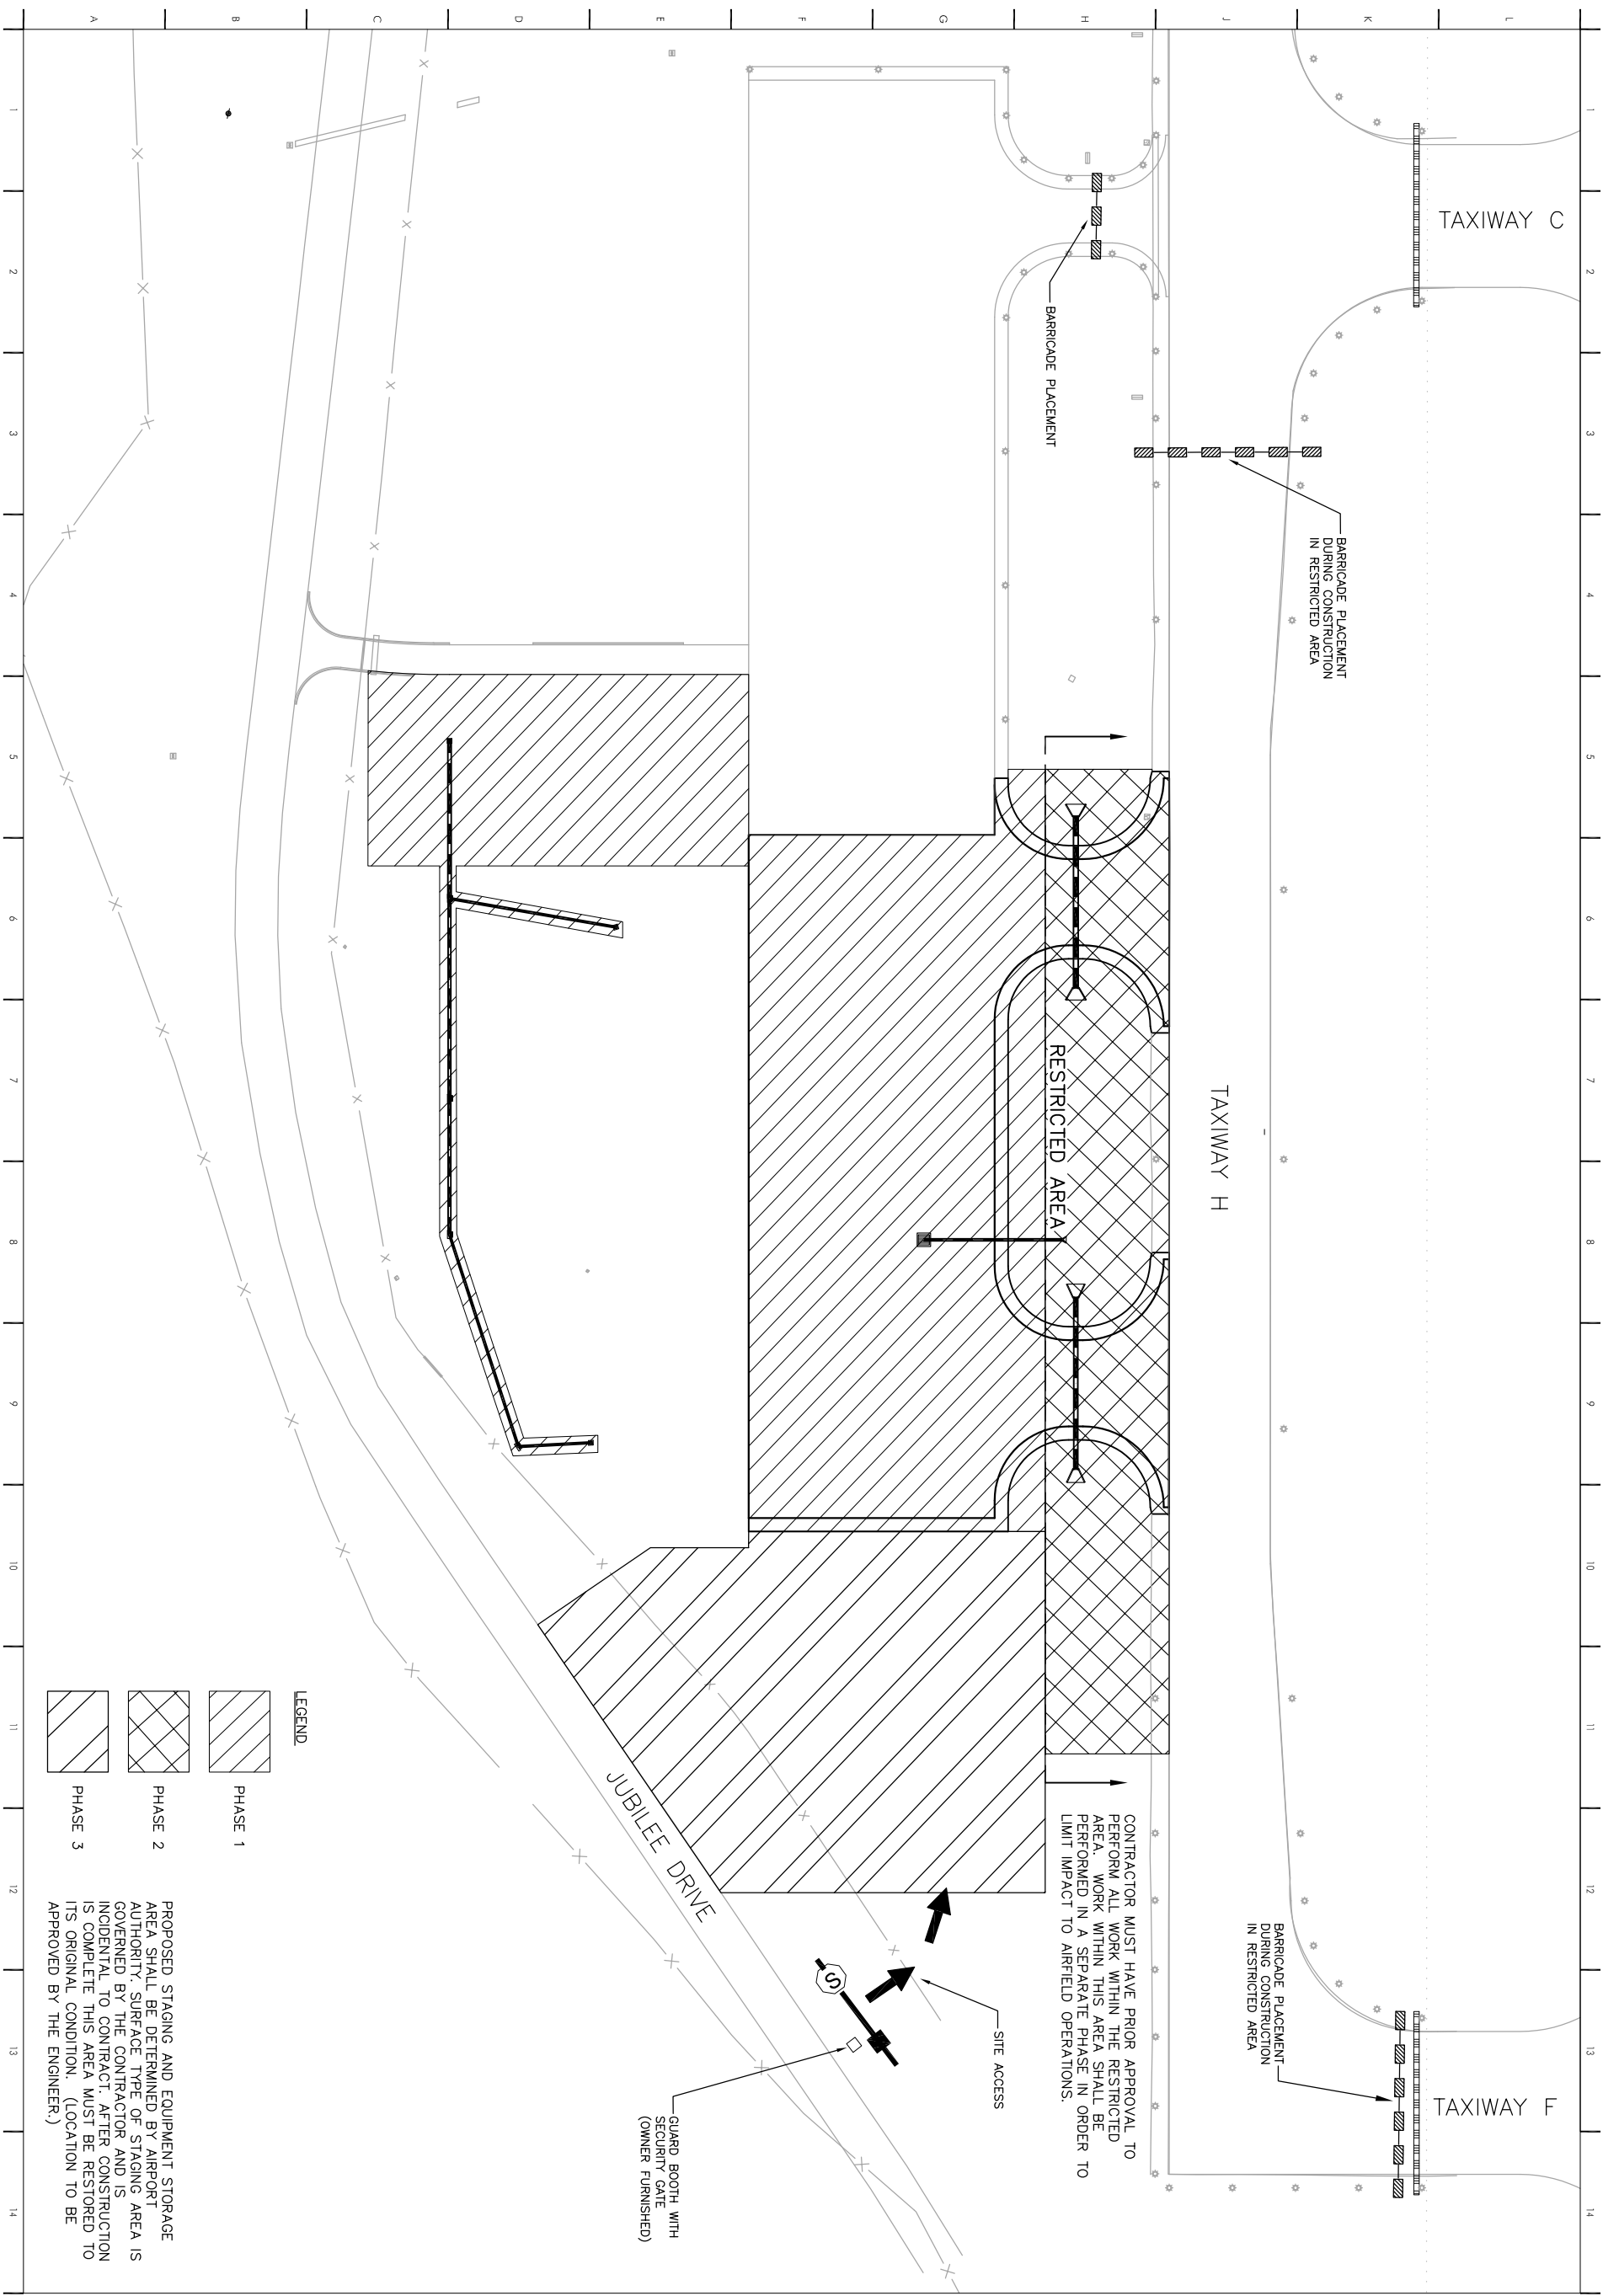

**LEGEND**

PHASE 1  
PHASE 2  
PHASE 3

PROPOSED STAGING AND EQUIPMENT STORAGE AREA SHALL BE DETERMINED BY AIRPORT AUTHORITY. SURFACE TYPE OF STAGING AREA IS GOVERNED BY THE CONTRACTOR AND IS INCIDENTAL TO CONTRACT. AFTER CONSTRUCTION IS COMPLETE THIS AREA MUST BE RESTORED TO ITS ORIGINAL CONDITION. (LOCATION TO BE APPROVED BY THE ENGINEER.)